


PARTIAL FIRST FLOOR PLAN

SCALE: 1/4" = 1'-0"

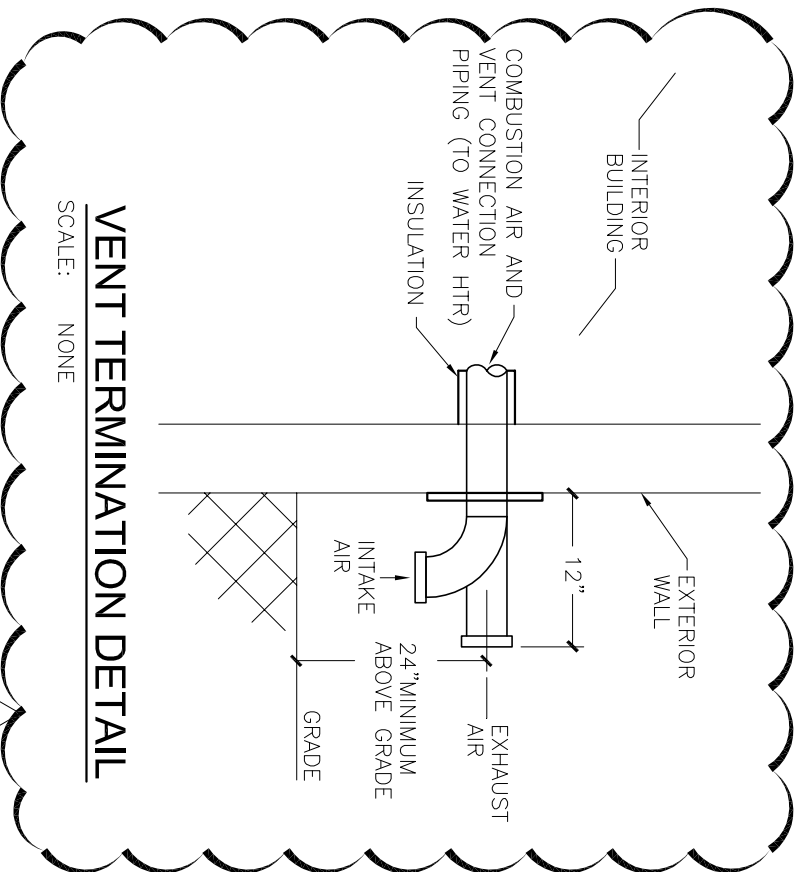

▲ WATER HEATER REVISION

Reference Dwg: M-101

KROMAC DESIGN
 MECHANICAL-ELECTRICAL ENGINEERING
 10225 Main Street
 Clarence, New York 14031
 Phone: (716) 803-8787
 Email: info@kromacdesign.com
 Fax: (716) 407-0552 KMD-20401-07

PROJECT TITLE:
 Wind Buffalo Renovation
 7566 Transit Rd
 Amherst, NY

DRAWING TITLE:
 PARTIAL FIRST FLOOR PLAN

PROJECT #: -
DATE: 04-26-20
SCALE: As Noted
DRAWING #: SK-M1